

the SNOW DRAGON

Lighting Plan

Director: Toby Mitchell

Designer: Polly Sullivan

Lighting Designer: Will Evans

Scale: 1:50 @A4







Date: 09/10/19 **VS:** Studio



This drawing and the design it represents are copyright and licensed only to this production, for the duration of the period

© Will Evans 2019

www.willevans.co.uk

Key

-  1K (or Source Four equiv) Narrow Zoom Profile
-  1.2Kw Fresnel
-  500/650w Fresnel
-  Par 64 CP62
-  Birdie (Toured)
-  500w Flood

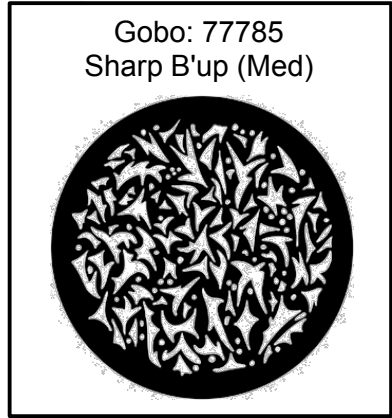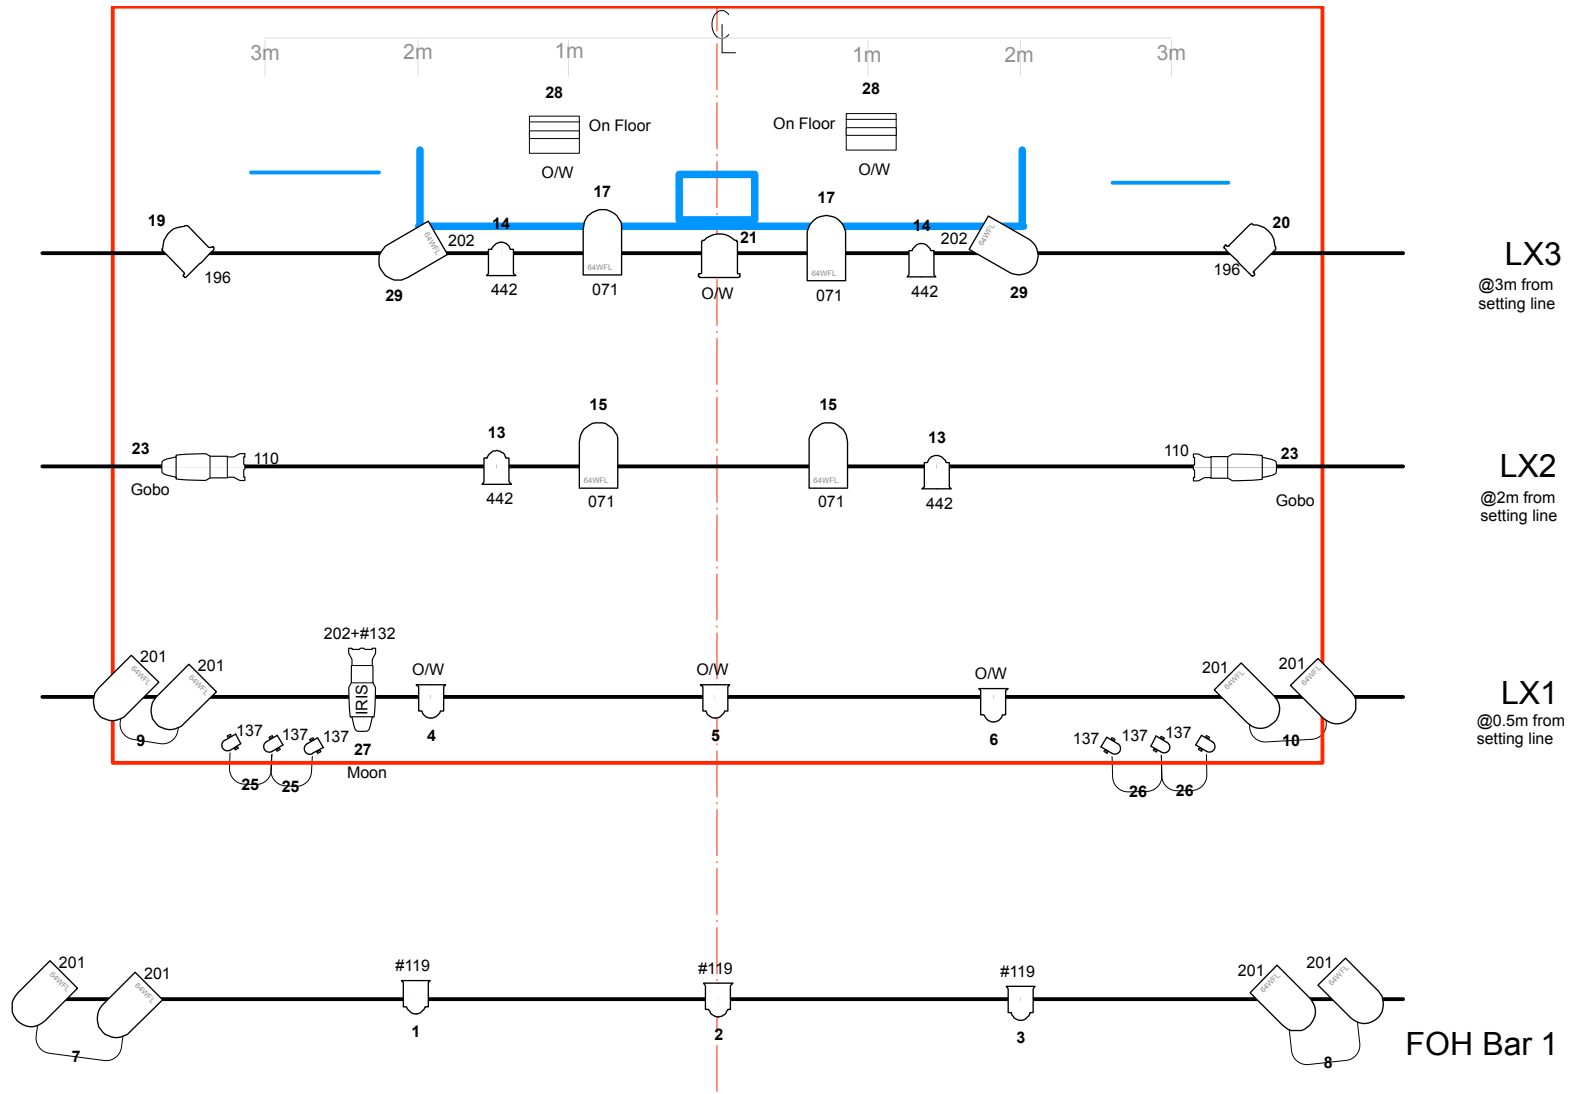

Other Things	
31	Lamp shades
33	Fairy Lights